


2023 MULLEN RD SEWER IMPROVEMENTS

LACEY CONTRACT # PW 2023-06
SECTION 35, T18N, R1W, W.M.

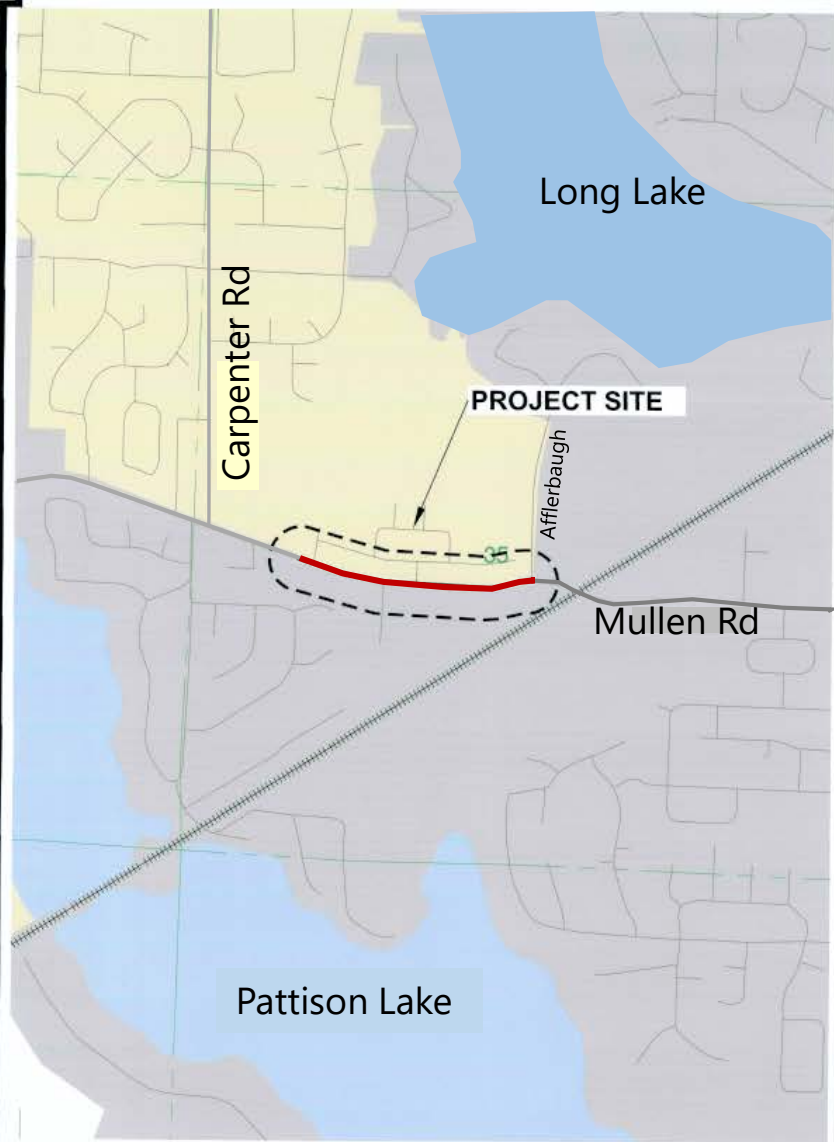

LACEY CITY OFFICIALS

MAYOR: Andy Ryder
DEPUTY MAYOR: Malcolm Miller
CITY COUNCIL: Lenny Greenstein
 Michael Steadman
 Carolyn Cox
 Ed Kunkel
 Robin Vazquez
CITY MANAGER: Rick Walk, Interim
CITY ATTORNEY: David Schneider
CITY ENGINEER: Aubrey Collier, P.E., S.E.
DIRECTOR OF PUBLIC WORKS: Scott Egger, P.E.

SHEET INDEX

SHEET NO.	PAGE NO.	DESCRIPTION
1	CS	COVER SHEET
2	GN	GENERAL NOTES
3-6	UT1-UT4	UTILITY PLANS
7-8	DT1-DT2	DETAIL SHEETS

Scott Egger
DIRECTOR OF PUBLIC WORKS

1/31/23
DATE

Project: PW 2023-06
Low Bidder: Miles Resources LLC
Low Bid: \$1,209,708.70
Engr Est: \$1,314,000.00
Bidders: 9
Working Days: 60
Begin Work: Spring 2023



VICINITY MAP
CITY OF LACEY, WASHINGTON
SCALE : 1" = 500'



LACEY CITY LIMITS
 OLYMPIA CITY LIMITS
 URBAN GROWTH AREA



Lacey Dwg. Number :
D-23-01

